
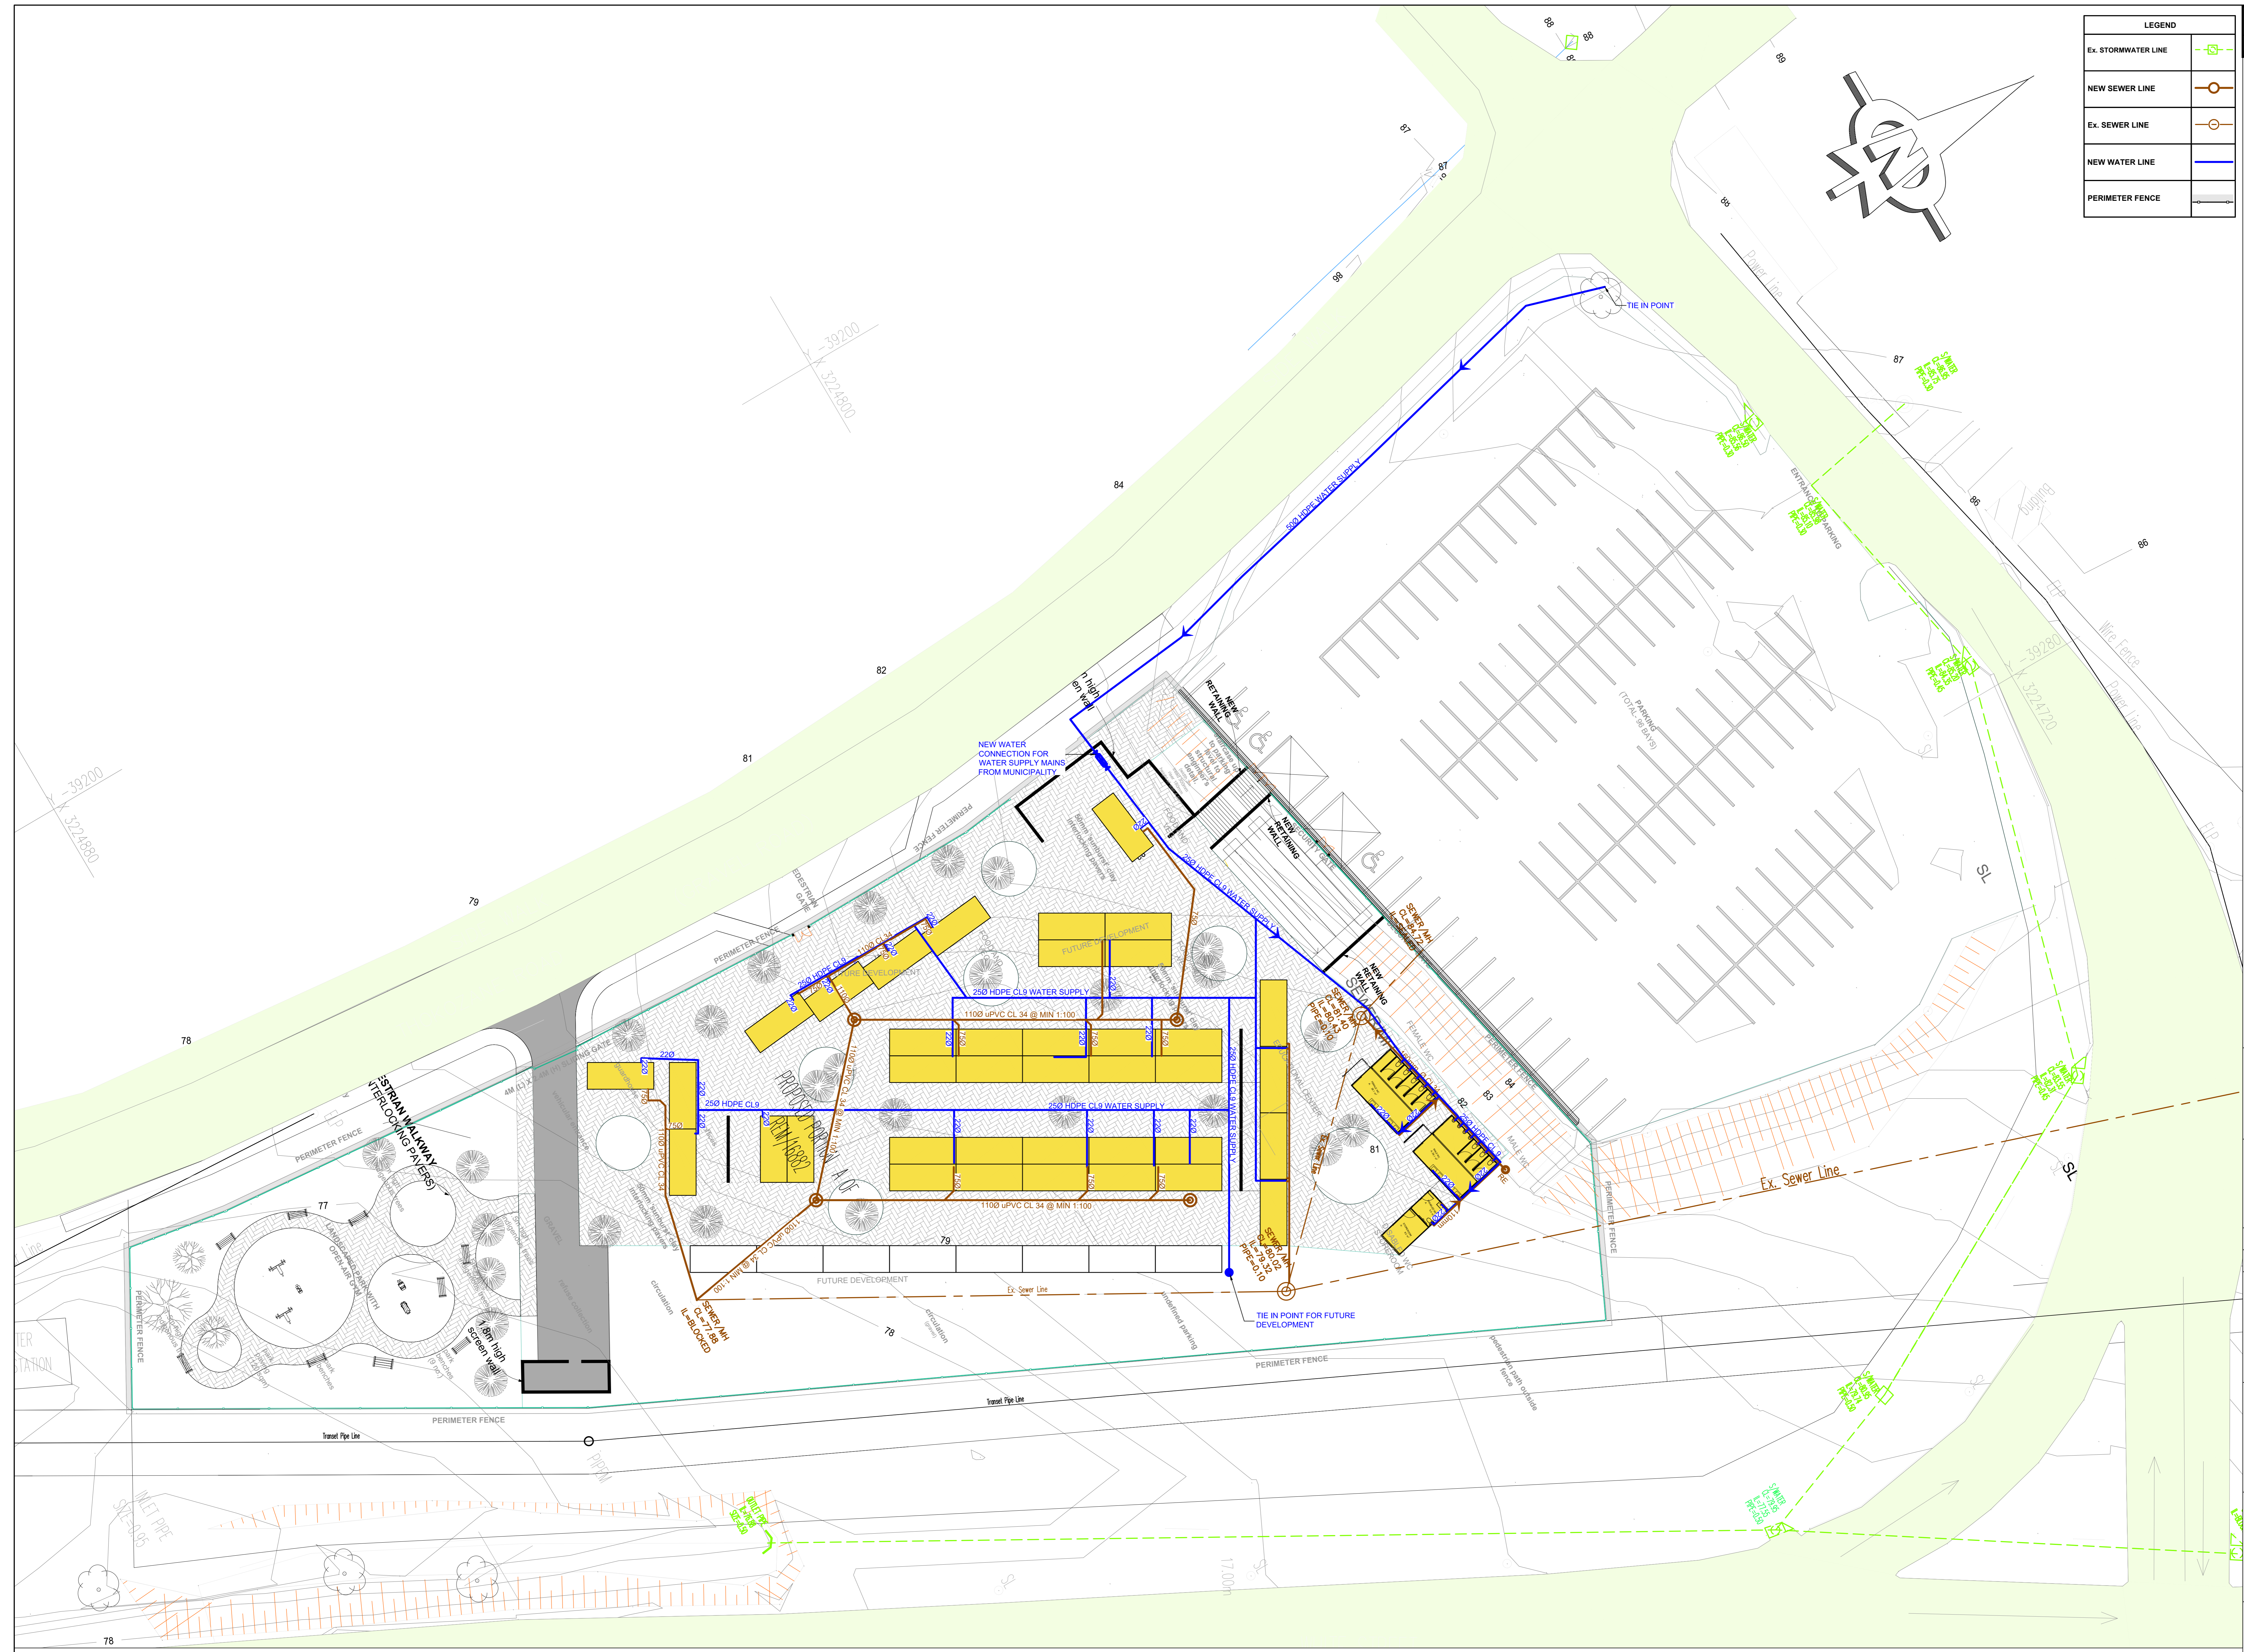


LEGEND	
Ex. STORMWATER LINE	
NEW SEWER LINE	
Ex. SEWER LINE	
NEW WATER LINE	
PERIMETER FENCE	

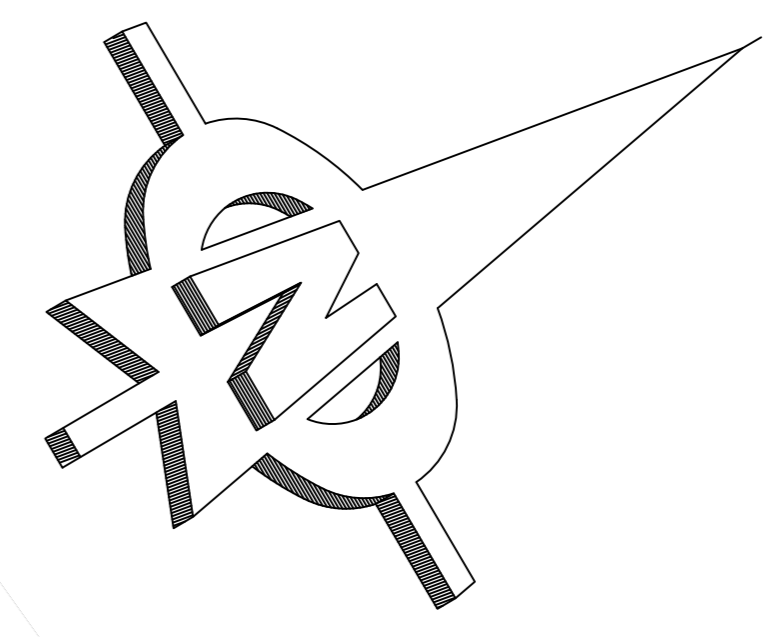

NOTES:

- All work to comply with the national building regulations sans 10400 & sans 1200
- Figured dimensions to be taken in preference to scaled dimensions. all dimensions and levels must be confirmed on site by contractor prior to the commencement of any work.
- This drawing is subject to copyright via the copyright act no. 98 of 1978. this drawing may not be distributed or copied without written permission of the author.

A	ISSUED FOR INFORMATION	JS	19/09/20
Rev.	Amendment	App.	Date

Delca Systems
 Development • Engineering • Logistics • Consulting, Africa
 18 Westville Road, Westville 3630
 P.O. Box 37064, Overport, 4067
 Tel: +27 31 266 5900
 Fax: +27 31 266 5926
 Email: info@delca.co.za

Client

Project
Mandeni Youth Enterprise Park

Description
SITE PLAN SERVICES

Approved	Designed by	SM
Date:	Drawn by	JS
	Checked by	SM

SITE PLAN
SCALE 1:200

ISSUED FOR INFORMATION